






CANTEEN & DRIVERS LOUNGE PERSPECTIVE DRAWING
SCALE : NTS

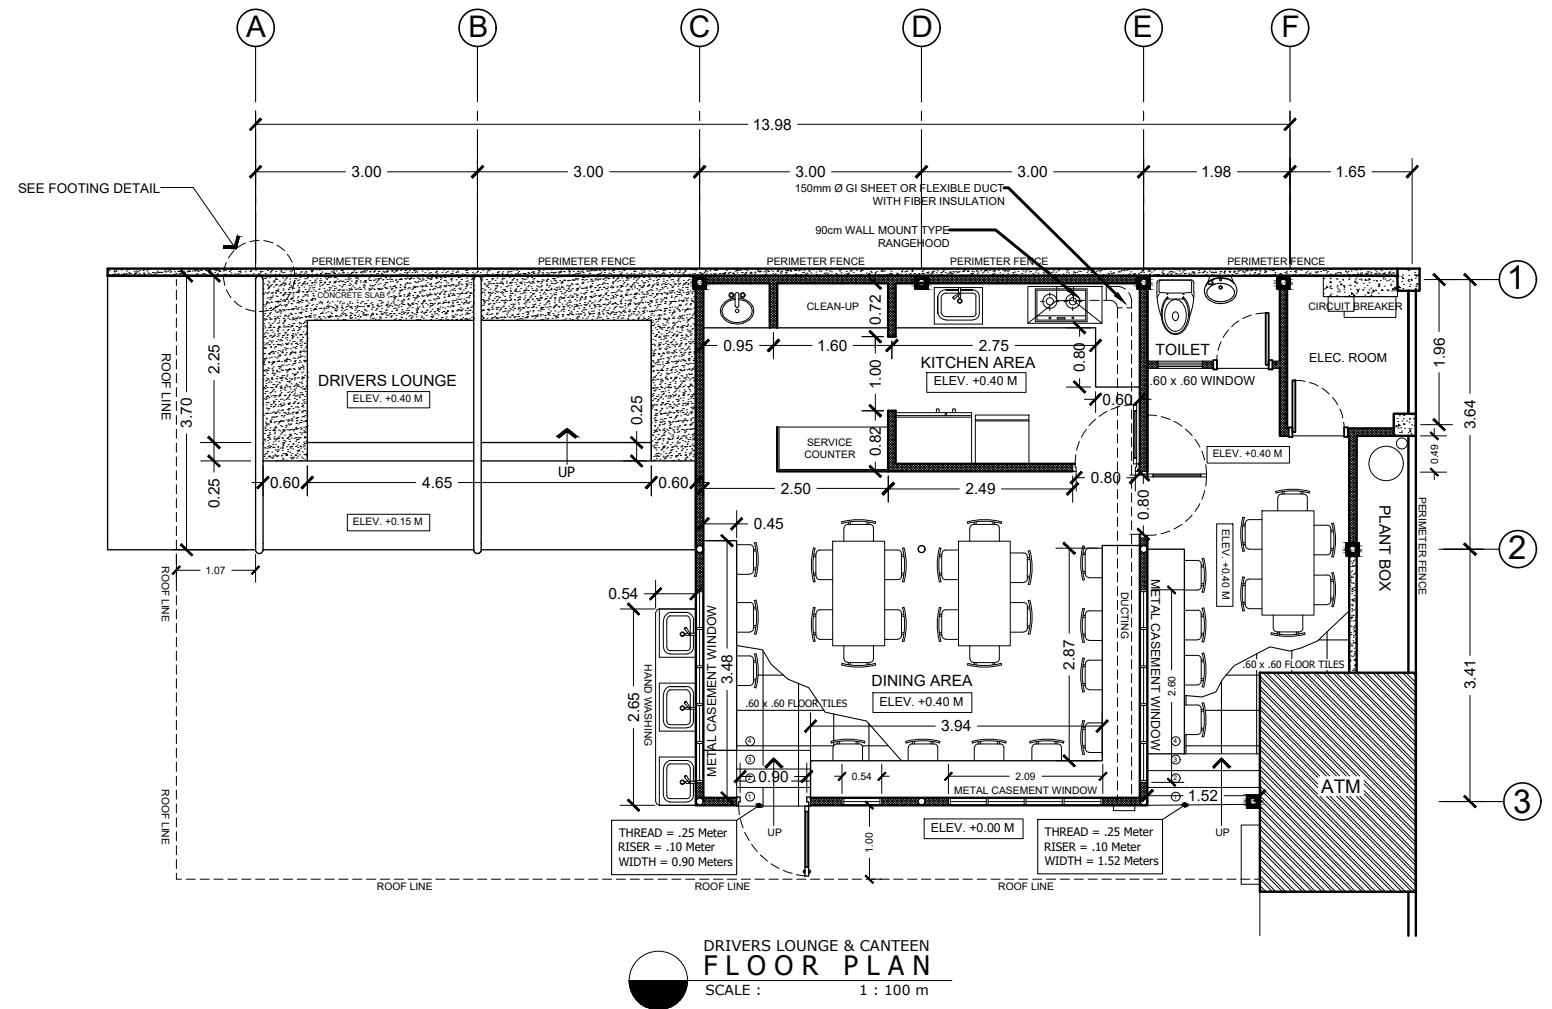


DRIVERS LOUNGE & CANTEEN
FLOOR PLAN
SCALE : 1 : 100 m

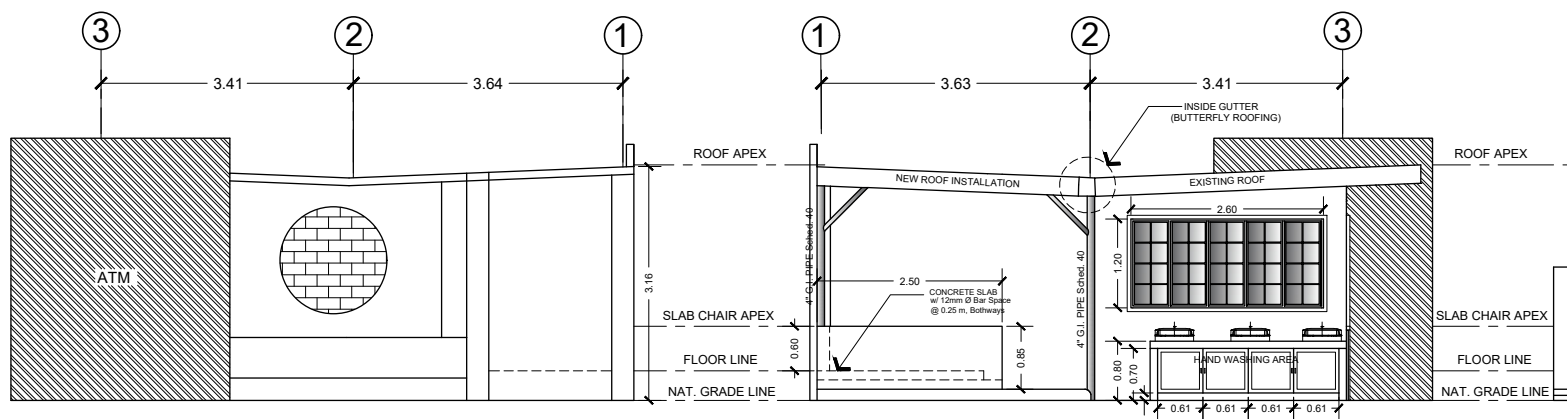

L. SIDE ELEVATION
SCALE : 1 : 100 m

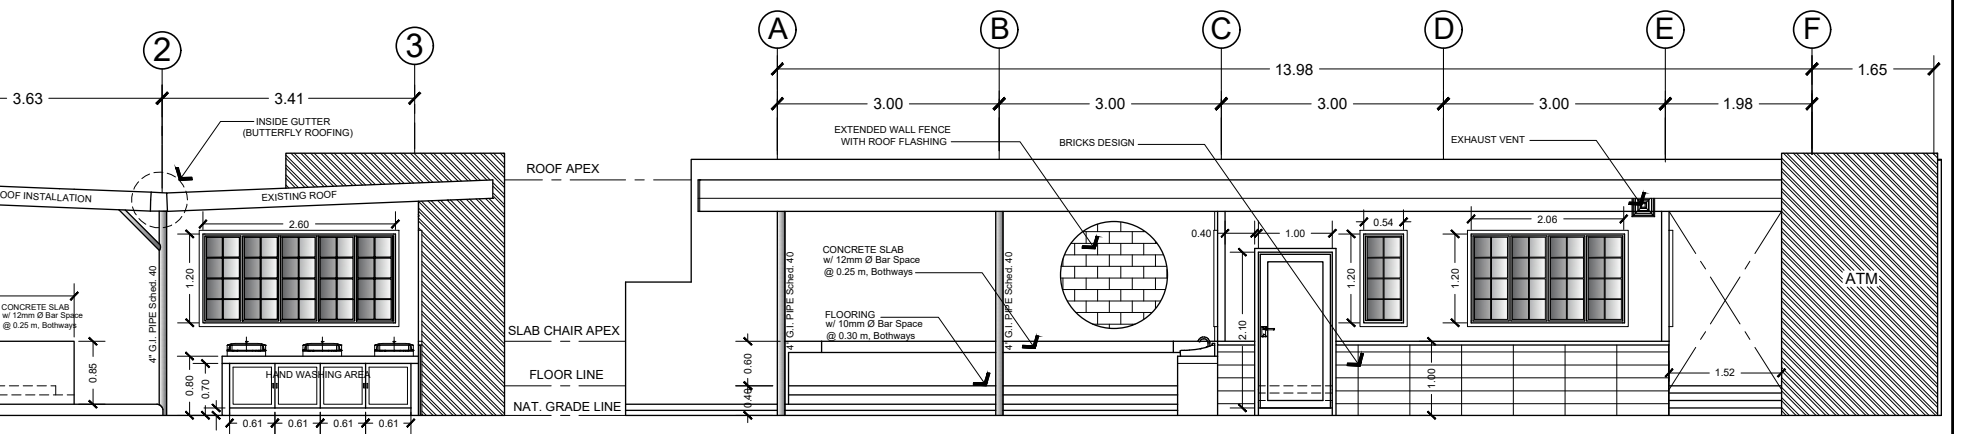



R. SIDE ELEVATION
SCALE : 1 : 100 m

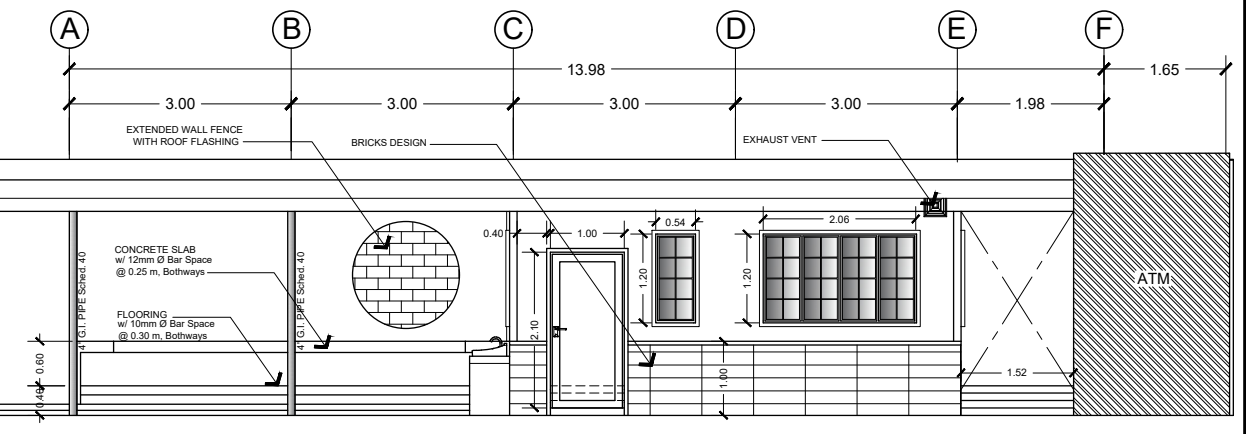


FRONT ELEVATION
SCALE : 1 : 100 m

Republic of the Philippines DepED DEPARTMENT OF EDUCATION REGIONAL OFFICE IV-A (CALABARZON) Karanglan Village, Gate 11, Carina, Raul	PREPARED BY: SIGNED EMIL O. REAMBILLO Draftsman II	CHECKED BY: SIGNED ENGR. ROBERT B. PEREZ Engineer III	RECOMMENDING APPROVAL: SIGNED EDUARDA M. ZAPANTA Chief Education Support Services Division	APPROVED: SIGNED FRANCIS CESAR B. BRINGAS Regional Director Office of the Regional Director	PROJECT: PROPOSED VARIOUS IMPROVEMENT AND REPAIR AT DEPED REGION IV-A	SHEET CONTENTS: CANTEEN & DRIVERS LOUNGE PERSPECTIVE DRAWING DRIVERS LOUNGE & CANTEEN FLOOR PLAN L. SIDE ELEVATION R. SIDE ELEVATION FRONT ELEVATION	SHEET NO. 3
---	---	--	--	---	---	--	---------------------------


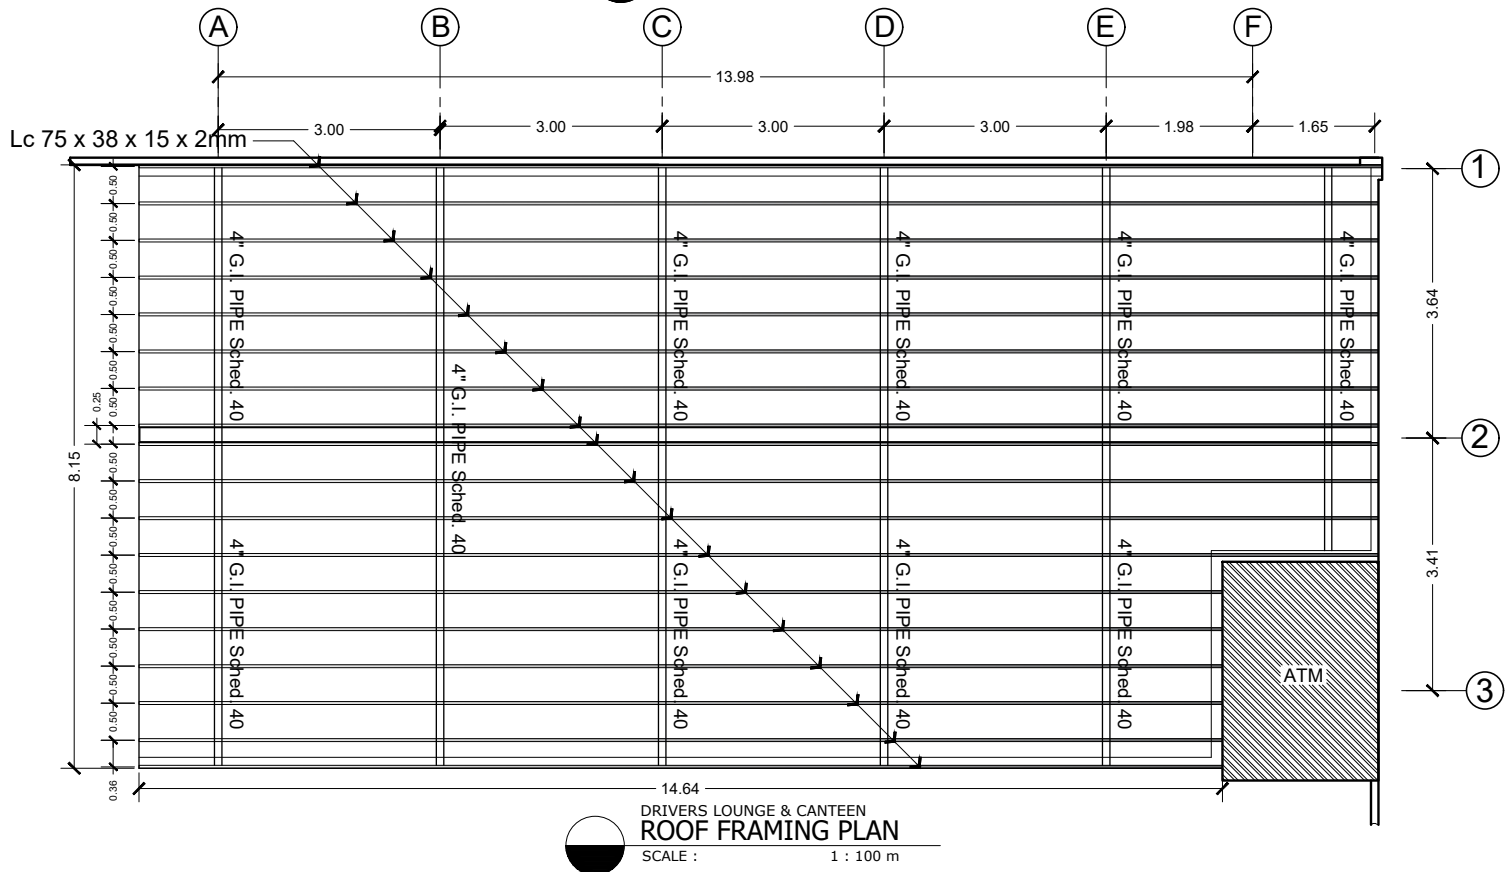


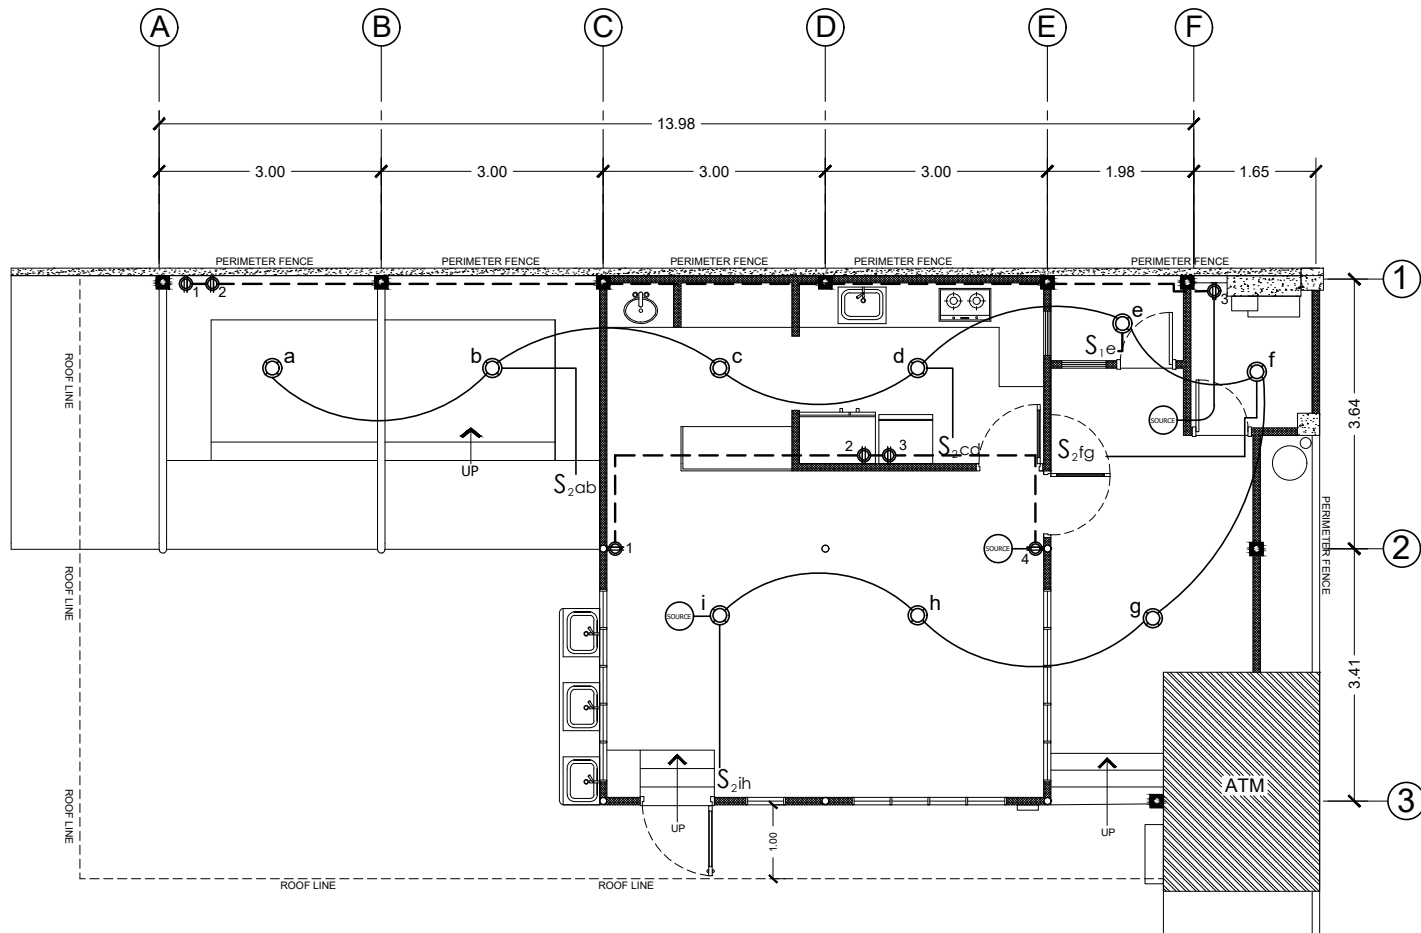

DRIVERS LOUNGE & CANTEEN
ELECTRICAL PLAN
SCALE : 1 : 100 m

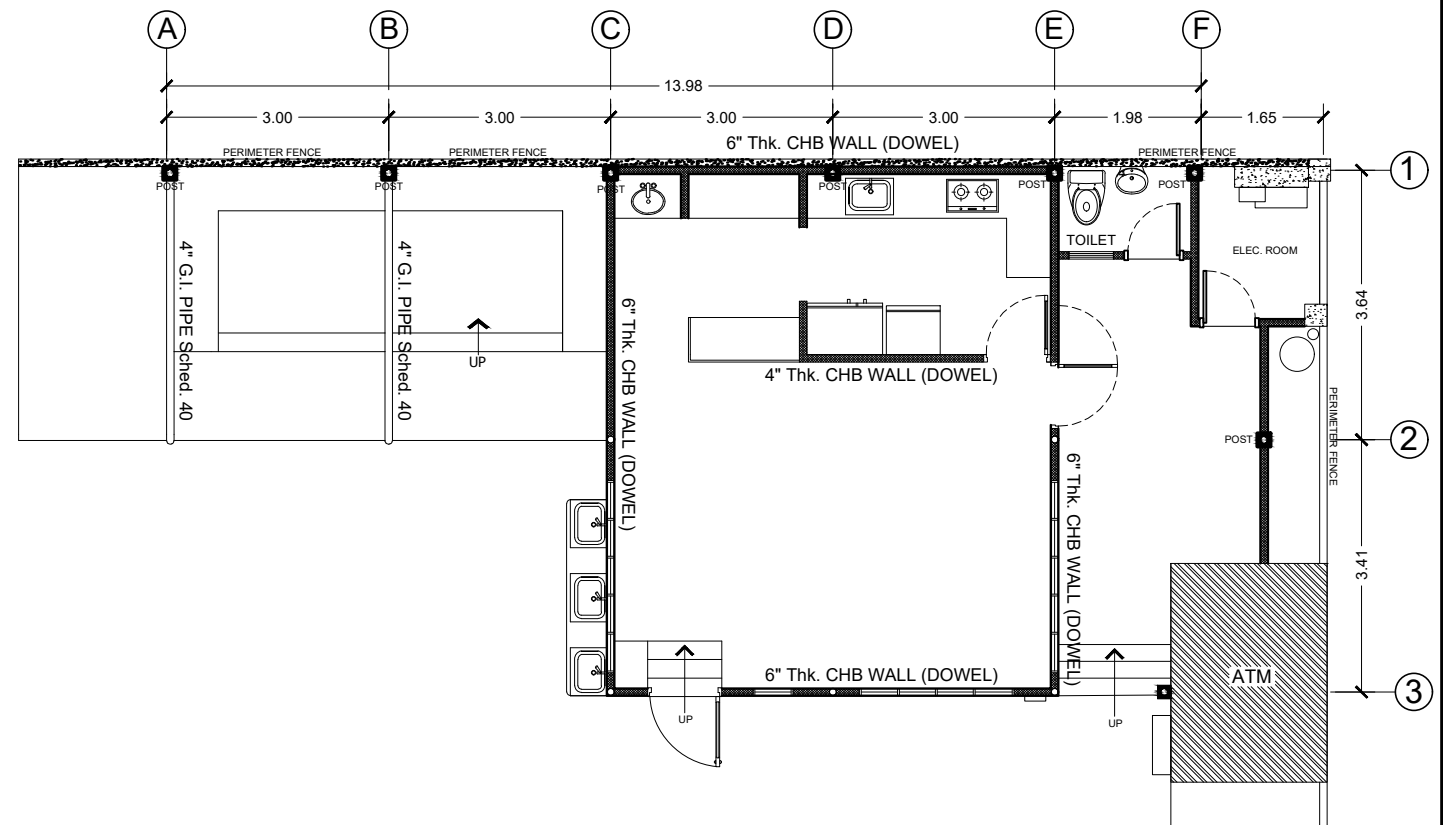

DRIVERS LOUNGE & CANTEEN
FOUNDATION PLAN
SCALE : 1 : 100 m

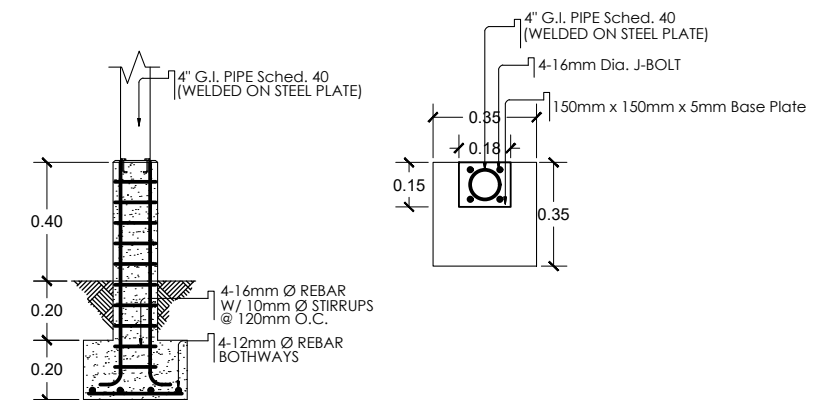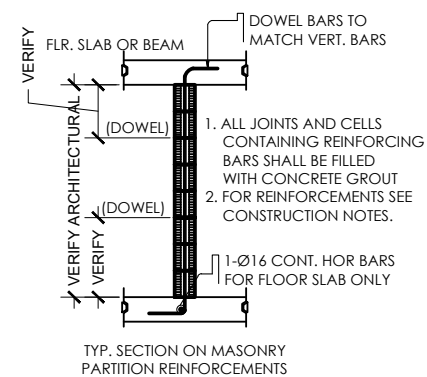

POST & FOOTING DETAIL
SCALE : 1 : 25 m

Republic of the Philippines DepED DEPARTMENT OF EDUCATION REGIONAL OFFICE IV-A (CALABARZON) Karanglan Village, Gate 11, Cavite, Rizal	PREPARED BY: SIGNED EMIL O. REAMBILLO Draftsman II	CHECKED BY: SIGNED ENGR. ROBERT B. PEREZ Engineer III	RECOMMENDING APPROVAL: SIGNED EDUARDA M. ZAPANTA Chief Education Support Services Division	APPROVED: SIGNED FRANCIS CESAR B. BRINGAS Regional Director Office of the Regional Director	PROJECT: PROPOSED VARIOUS IMPROVEMENT AND REPAIR AT DEPED REGION IV-A	SHEET CONTENTS: DRIVERS LOUNGE & CANTEEN ELECTRICAL PLAN DRIVERS LOUNGE & CANTEEN FOUNDATION PLAN DRIVERS LOUNGE & CANTEEN POST & FOOTING DETAIL	SHEET NO. 5
---	---	--	---	--	---	--	----------------------------------